

GENERAL NOTES

- ALL WORK SHALL BE DONE IN ACCORDANCE WITH THE CITY REQUIREMENTS.
- THE CONTRACTOR SHALL TAKE DUE PRECAUTIONARY MEASURES TO PROTECT THE UTILITY LINES SHOWN AND ANY OTHER UTILITIES NOT OF RECORD OR NOT SHOWN ON THESE PLANS.
- ALL WORK SHALL BE CONSTRUCTED IN ACCORDANCE WITH THE CITY'S STANDARD PLANS, PROJECT PLANS, SPECIFICATIONS, AND CONTRACT DOCUMENTS. THE CONTRACTOR SHALL KEEP A COPY OF THIS INFORMATION ON THE JOBSITE.
- A RECONSTRUCTION MEETING SHALL BE HELD A MINIMUM OF 48 HOURS PRIOR TO COMMENCING WORK.
- THE CONTRACTOR SHALL NOTIFY THE CITY'S CONSTRUCTION MANAGER, MANUEL FABIAN @ (818) 898-1243, A MINIMUM OF 5 WORKING DAYS PRIOR TO THE START OF CONSTRUCTION AND 48 HOURS IN ADVANCE OF INSPECTION REQUESTS.
- PROJECT STATIONING REFERS TO THE CENTERLINE OF THE STREET.
- STOCK PILING OF REMOVED MATERIAL WILL NOT BE ALLOWED IN OR AROUND THE PROJECT SITE. THE CONTRACTOR SHALL BE RESPONSIBLE FOR HAULING OFF ALL EXCESS MATERIALS GENERATED DURING THE CONSTRUCTION OF THIS PROJECT TO AN APPROVED DISPOSAL SITE.
- DUST SHALL BE CONTROLLED WITH WATER OR AS REQUIRED UNDER THE DIRECTION OF THE INSPECTOR/PROJECT MANAGER.
- REMOVAL OF ALL VEGETATION AND DEBRIS PRIOR TO ANY GRADING IS REQUIRED.
- NO EXCAVATION SHALL BE LEFT OPEN AFTER DAYLIGHT HOURS, EXCAVATIONS SHALL BE BACKFILLED AND PAVEMENT REPLACED OR BRIDGED WITH TRAFFIC RATED STEEL PLATES.
- CONTRACTOR WORK SHALL BE 7:00 AM TO 4:00 PM MONDAY THRU FRIDAY, EXCLUDING HOLIDAYS, UNLESS OTHERWISE ACCEPTED BY THE CITY. ALL WORK WITHIN VEHICULAR TRAFFIC LANES SHALL BE LIMITED TO 9:00 AM AND 3:00 PM.
- A CITY APPROVED TRAFFIC CONTROL PLAN PER LATEST EDITION OF THE WATCH HANDBOOK SHALL BE SECURED 48 HOURS PRIOR TO CONSTRUCTION.
- INSTALL TAR PAPER AROUND POWER POLES PRIOR TO LAYING A.C. PAVEMENT IN ALLEYS.
- PROVIDE 2" X 4" REDWOOD HEADERS AT PROPERTY LINES WHERE PROPOSED PAVEMENT IS CONSTRUCTED ADJACENT TO DIRT OR UNPAVED AREA, OR ADJACENT TO WOOD, METAL OR CHAIN LINE FENCE.
- JOIN NEW A.C. PAVEMENT TO EXISTING A.C. & CONC. PAVEMENT AT PROPERTY LINE. SAW-CUT AS NECESSARY AND PROVIDE TACK COAT.
- THE SUBGRADE OF THE DRIVEWAY AND PARKING AREAS SHALL BE SCARIFIED, BROUGHT TO OPTIMUM MOISTURE CONTENT 90%, COMPACTION ACTIVITIES SHALL BE INSPECTED BY CITY PRIOR TO PLACING CRUSHED MISCELLANEOUS BASE AND CASTING OF CONCRETE.


NOTICE TO CONTRACTOR:

IT SHALL BE THE SOLE RESPONSIBILITY OF THE CONTRACTOR TO CALL THE USA UNDERGROUND ALERT FOR LOCATION OF EXISTING UNDERGROUND UTILITIES NO LESS THAN TWO DAYS NOR MORE THAN SEVEN DAYS PRIOR TO CONSTRUCTION.

811

THE CONTRACTOR SHALL ASSUME SOLE RESPONSIBILITY FOR ANY DAMAGE DONE TO EXISTING UTILITIES OR STREET IMPROVEMENTS INCLUDING CONCRETE/LANDSCAPING DURING CONSTRUCTION.

UNDERGROUND SERVICE ALERT

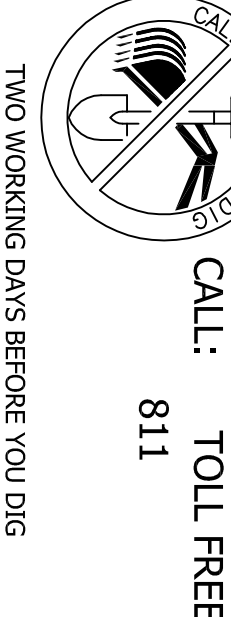

REV.	DATE	BY	DESCRIPTION	APPROVED



SAN FERNANDO

PUBLIC WORKS DEPARTMENT

SAN FERNANDO ROAD IMPROVEMENTS BETWEEN S HUNTINGTON STREET AND SAN FERNANDO MISSION BLVD CDBG PROJECT NO. 601994-18 PROJECT NO. 7606, PLAN NO. 729

CONSTRUCTION NOTES

- COLD MILL 1.5" AC PAVEMENT
- CONSTRUCT 1.5" THICK ARRM OVERLAY
- REMOVE AND REPLACE 4" THICK PCC SIDEWALK
- REMOVE AND REPLACE PCC CURB PER SPWVC STANDARD PLAN 120-2
- REMOVE AND REPLACE 6" THICK PCC DRIVE APPROACH PER SPWVC STANDARD PLAN 110-2, TYPE A
- REMOVE EXISTING PCC DRIVE APPROACH AND CONSTRUCT 4" THICK PCC SIDEWALK
- CONSTRUCT CURB RAMP WITH TRUNCATED DOME
- REMOVE EXISTING PCC SPANDREL
- REMOVE EXISTING PCC SIDEWALK AND CONSTRUCT 6" THICK PCC DRIVE APPROACH
- ADJUST MANHOLE COVER TO GRADE
- ADJUST GATE VALVE COVER TO GRADE
- PROVIDE TRAFFIC STRIPING, PAVEMENT MARKING, OR REFLECTIVE PAVEMENT MARKERS
- PROVIDE AND INSTALL TYPE E VEHICLE LOOPS PER SPWVC STANDARD PLAN 457-1
- REMOVE AND RECONSTRUCT PARKWAY DRAIN PER SPWVC STANDARD PLAN 151-2

DISPOSITION NOTES

- ☐ PROTECT IN PLACE

SHEET INDEX

SHEET NO.	DESCRIPTION
1	TITLE SHEET
2	STREET IMPROVEMENT PLAN
3	STRIPING PLAN



PUBLIC UTILITIES

- WATER:**
CITY OF SAN FERNANDO
120 MACNEIL STREET
SAN FERNANDO, CA 91340
TONY SALAZAR OR DANNY GARCIA
818 898 1293
- FIRE:**
CITY OF LOS ANGELES FIRE DEPARTMENT STA. 91
14430 POLK STREET
LOS ANGELES, CA
NON-EMERGENCY NUMBER
818 756 8691
- OIL:**
PLAINS ALL AMERICAN
5900 CHERRY AVE
LONG BEACH, CA
EMERGENCY NUMBER
800 708 5071
- ELECTRICITY:**
SOUTHERN CALIFORNIA EDISON COMPANY
EMERGENCY CALLS
800 611 1911
- GAS:**
SOUTHERN CALIFORNIA GAS COMPANY
EMERGENCY CALLS
800 427 2200
- TELEPHONE:**
FRONTIER COMMUNICATIONS
EMERGENCY CALLS
800 483 1000
- CABLE:**
SPECTRUM
EMERGENCY CALLS
818 700 6500

LEGEND


- STREET LIGHT
SMH
SEWER MANHOLE
S
MAIL BOX
MB
LOOP DETECTORS
SIGN
POWER POLE
SDMH
STORM DRAIN MANHOLE
TSD
TRAFFIC SIGNAL BOX
GAS METER
OIL VALVE
- TRAFFIC SIGNAL
PULL BOX
FIRE HYDRANT
WATER METER
WATER VALVE
WATER MAIN LINE
GAS V
GAS VALVE
LIGHT POLE
GAS LINE

LOCATION MAP

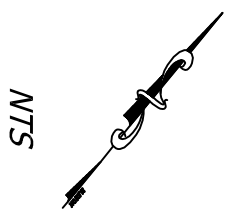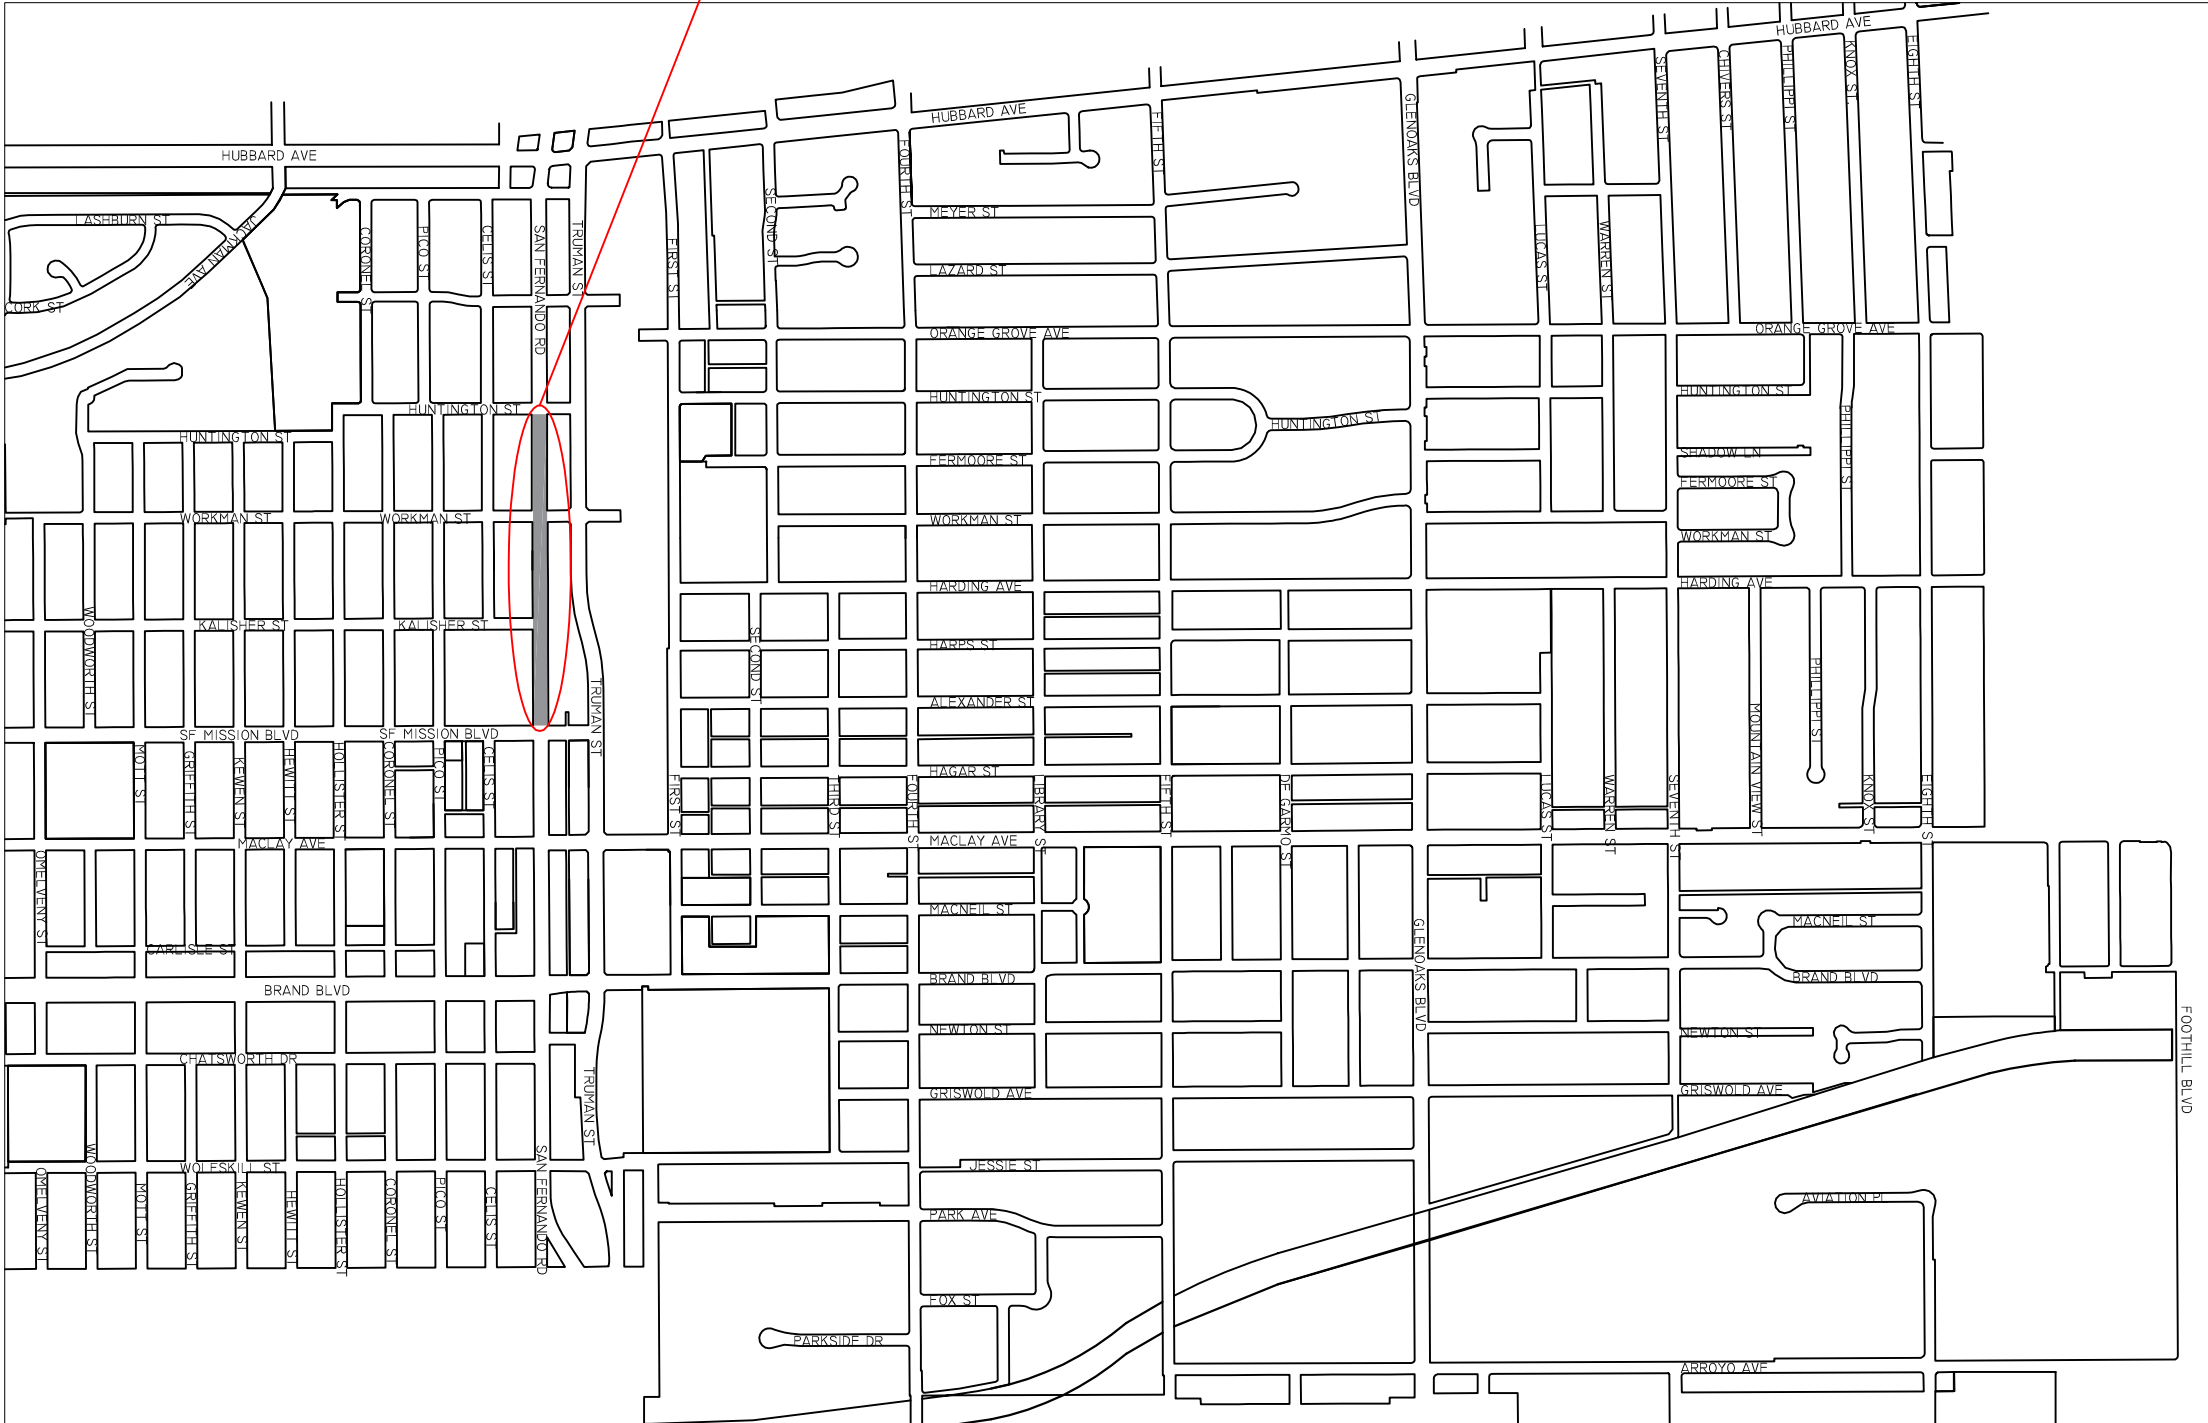

SAN FERNANDO ROAD STREET IMPROVEMENTS
BETWEEN S HUNTINGTON STREET AND SAN FERNANDO MISSION BLVD
TITLE SHEET
CDBG PROJECT NO. 601994-18
PROJECT NO. 7606, PLAN NO. P-729

SHEET NO. 1
OF 3

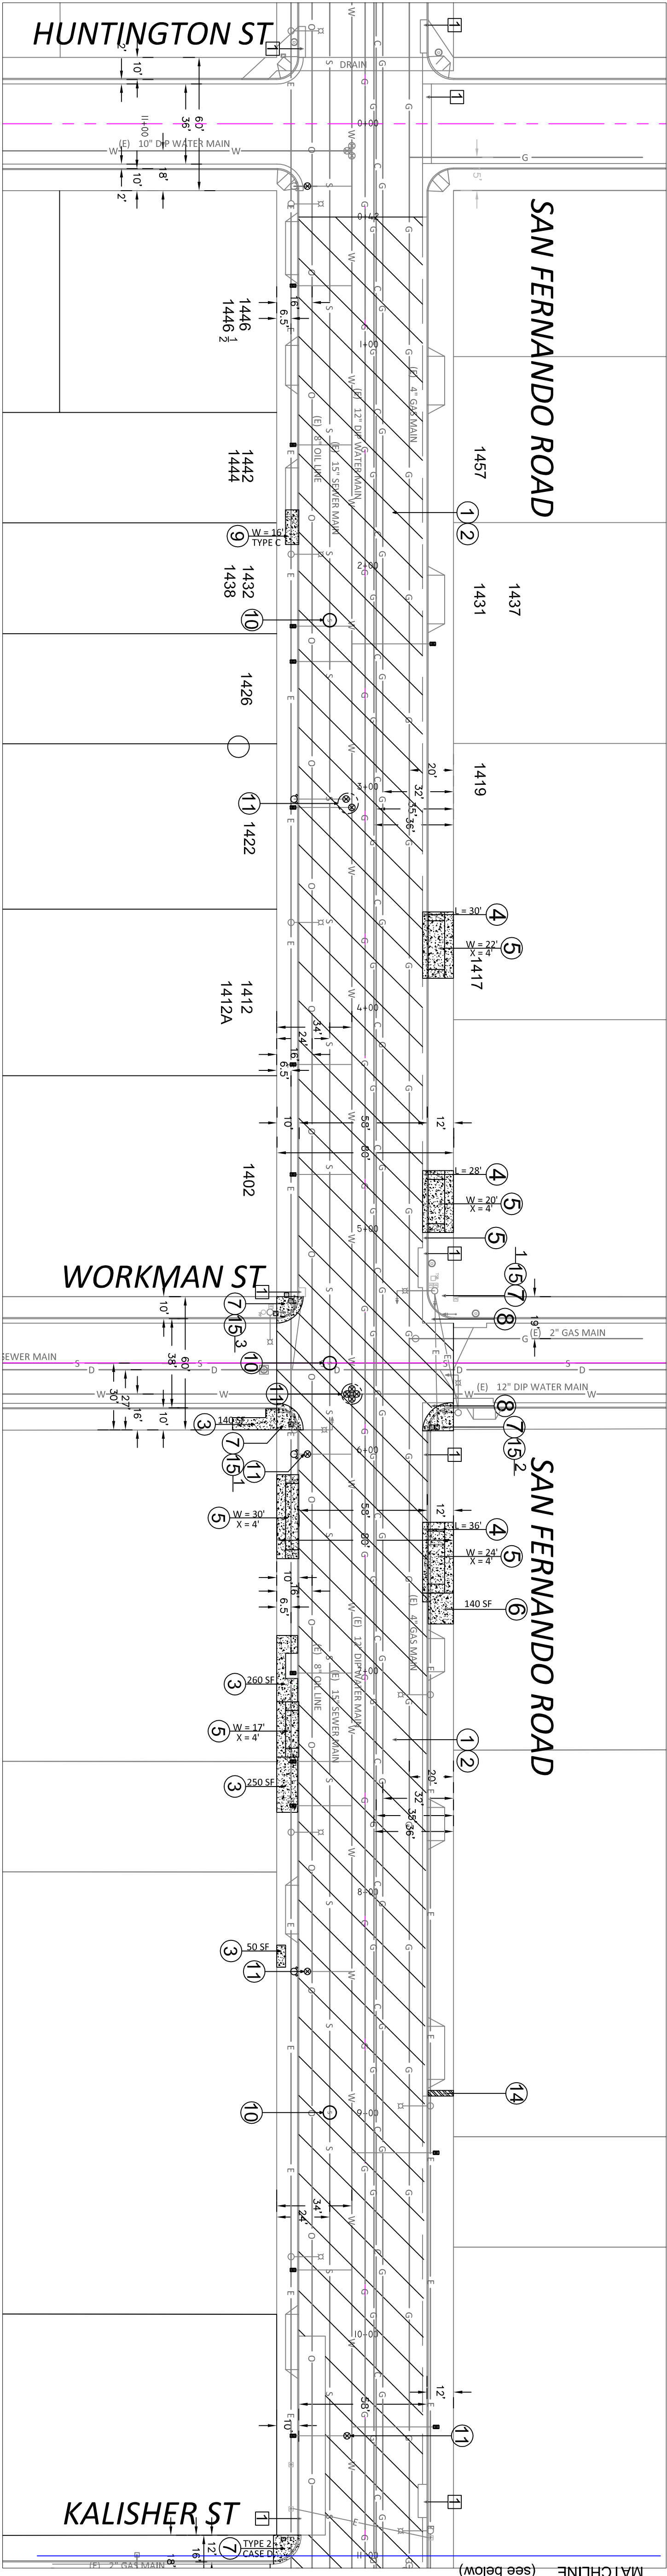

CONSTRUCTION NOTES

- 1 COLD MILL 1.5" AC PAVEMENT
- 2 CONSTRUCT 1.5" THICK ARHM OVERLAY
- 3 REMOVE AND REPLACE 4" THICK PCC SIDEWALK
- 4 REMOVE AND REPLACE PCC CURB AND GUTTER PER SPWVC STANDARD PLAN 120-2
- 5 REMOVE AND REPLACE 6" THICK PCC DRIVE APPROACH PER SPWVC STANDARD PLAN 110-2, TYPE A*
- 6 REMOVE EXISTING PCC DRIVE APPROACH AND CONSTRUCT 4" THICK PCC SIDEWALK*
- 7 CONSTRUCT CURB RAMP WITH TRUNCATED DOME
- 8 REMOVE EXISTING PCC SPANDREL AND REPLACE WITH AC PAVEMENT
- 9 REMOVE EXISTING PCC SIDEWALK AND CONSTRUCT 6" THICK PCC DRIVE APPROACH*
- 10 ADJUST MANHOLE COVER TO GRADE
- 11 ADJUST GATE VALVE COVER TO GRADE
- 12 PROVIDE TRAFFIC STRIPING, PAVEMENT MARKING, OR REFLECTIVE PAVEMENT MARKERS
- 13 PROVIDE AND INSTALL TYPE E VEHICLE LOOPS PER SPWVC STANDARD PLAN 457-1
- 14 REMOVE AND RECONSTRUCT PARKWAY DRAIN PER SPWVC STANDARD PLAN 151-2
- 15 ADJUST UTILITY PULL BOX TO GRADE




*WHERE THERE IS CURB ONLY, THE CURB, INCLUDING THE AC SLOT, SHALL BE INCLUDED IN THE PAYMENT FOR THE SIDEWALK/DRIVE APPROACH.

DISPOSITION NOTES

- 17 PROTECT IN PLACE

LEGEND

- | | |
|---------------------|-----------------|
| STREET LIGHT | TRAFFIC SIGNAL |
| SEWER MANHOLE | PULL BOX |
| SEWER MAIN LINE | FIRE HYDRANT |
| MAIL BOX | WATER METER |
| LOOP DETECTORS | WATER VALVE |
| POWER POLE | WATER MAIN LINE |
| STORM DRAIN MANHOLE | GAS VALVE |
| WALL T | LIGHT POLE |
| TRAFFIC SIGNAL BOX | GAS LINE |
| GAS METER | |
| OIL VALVE | |

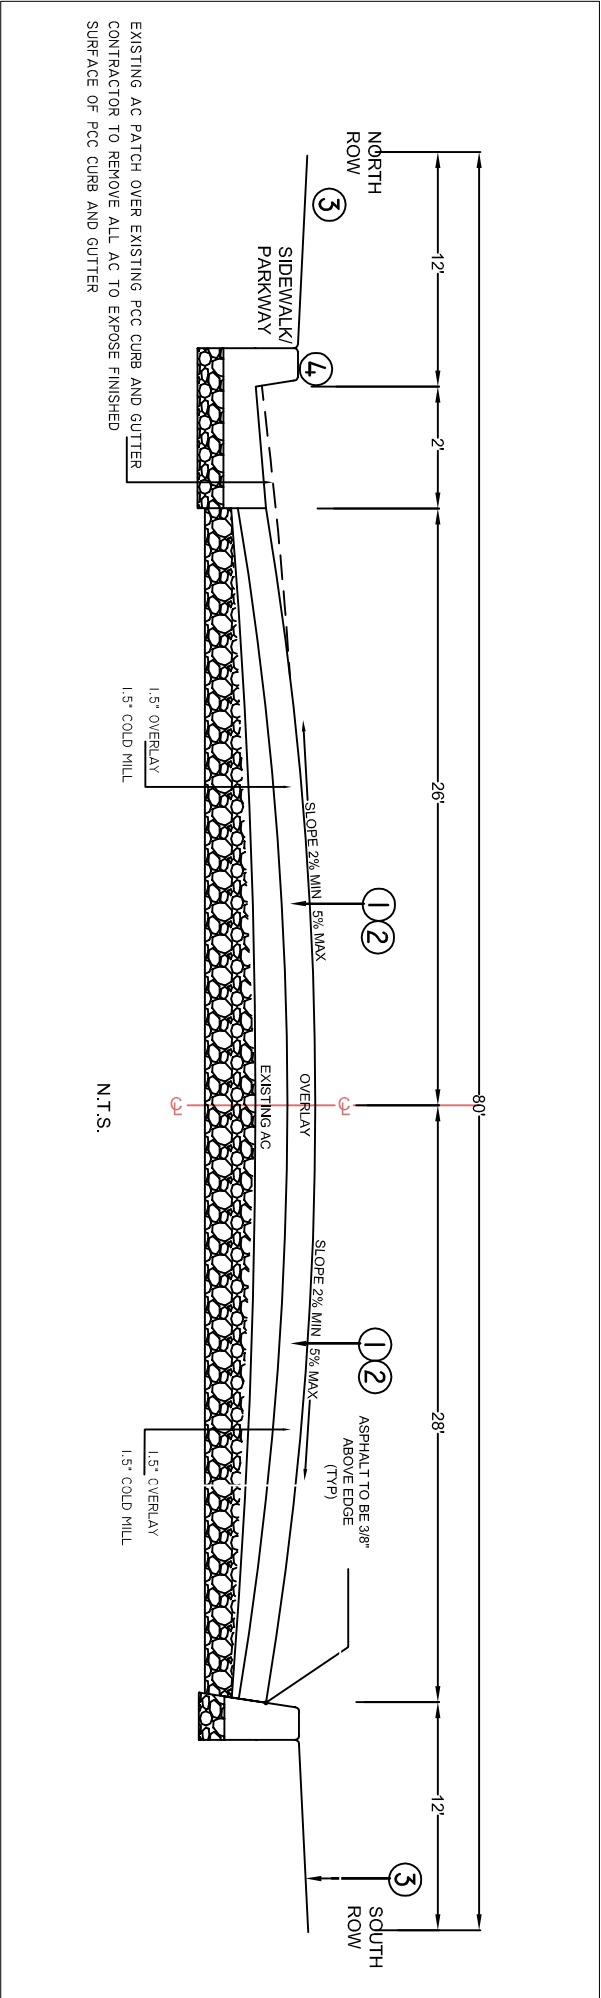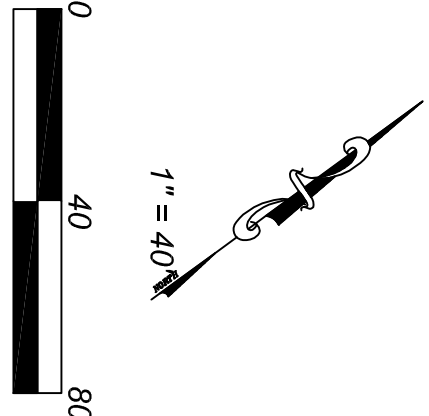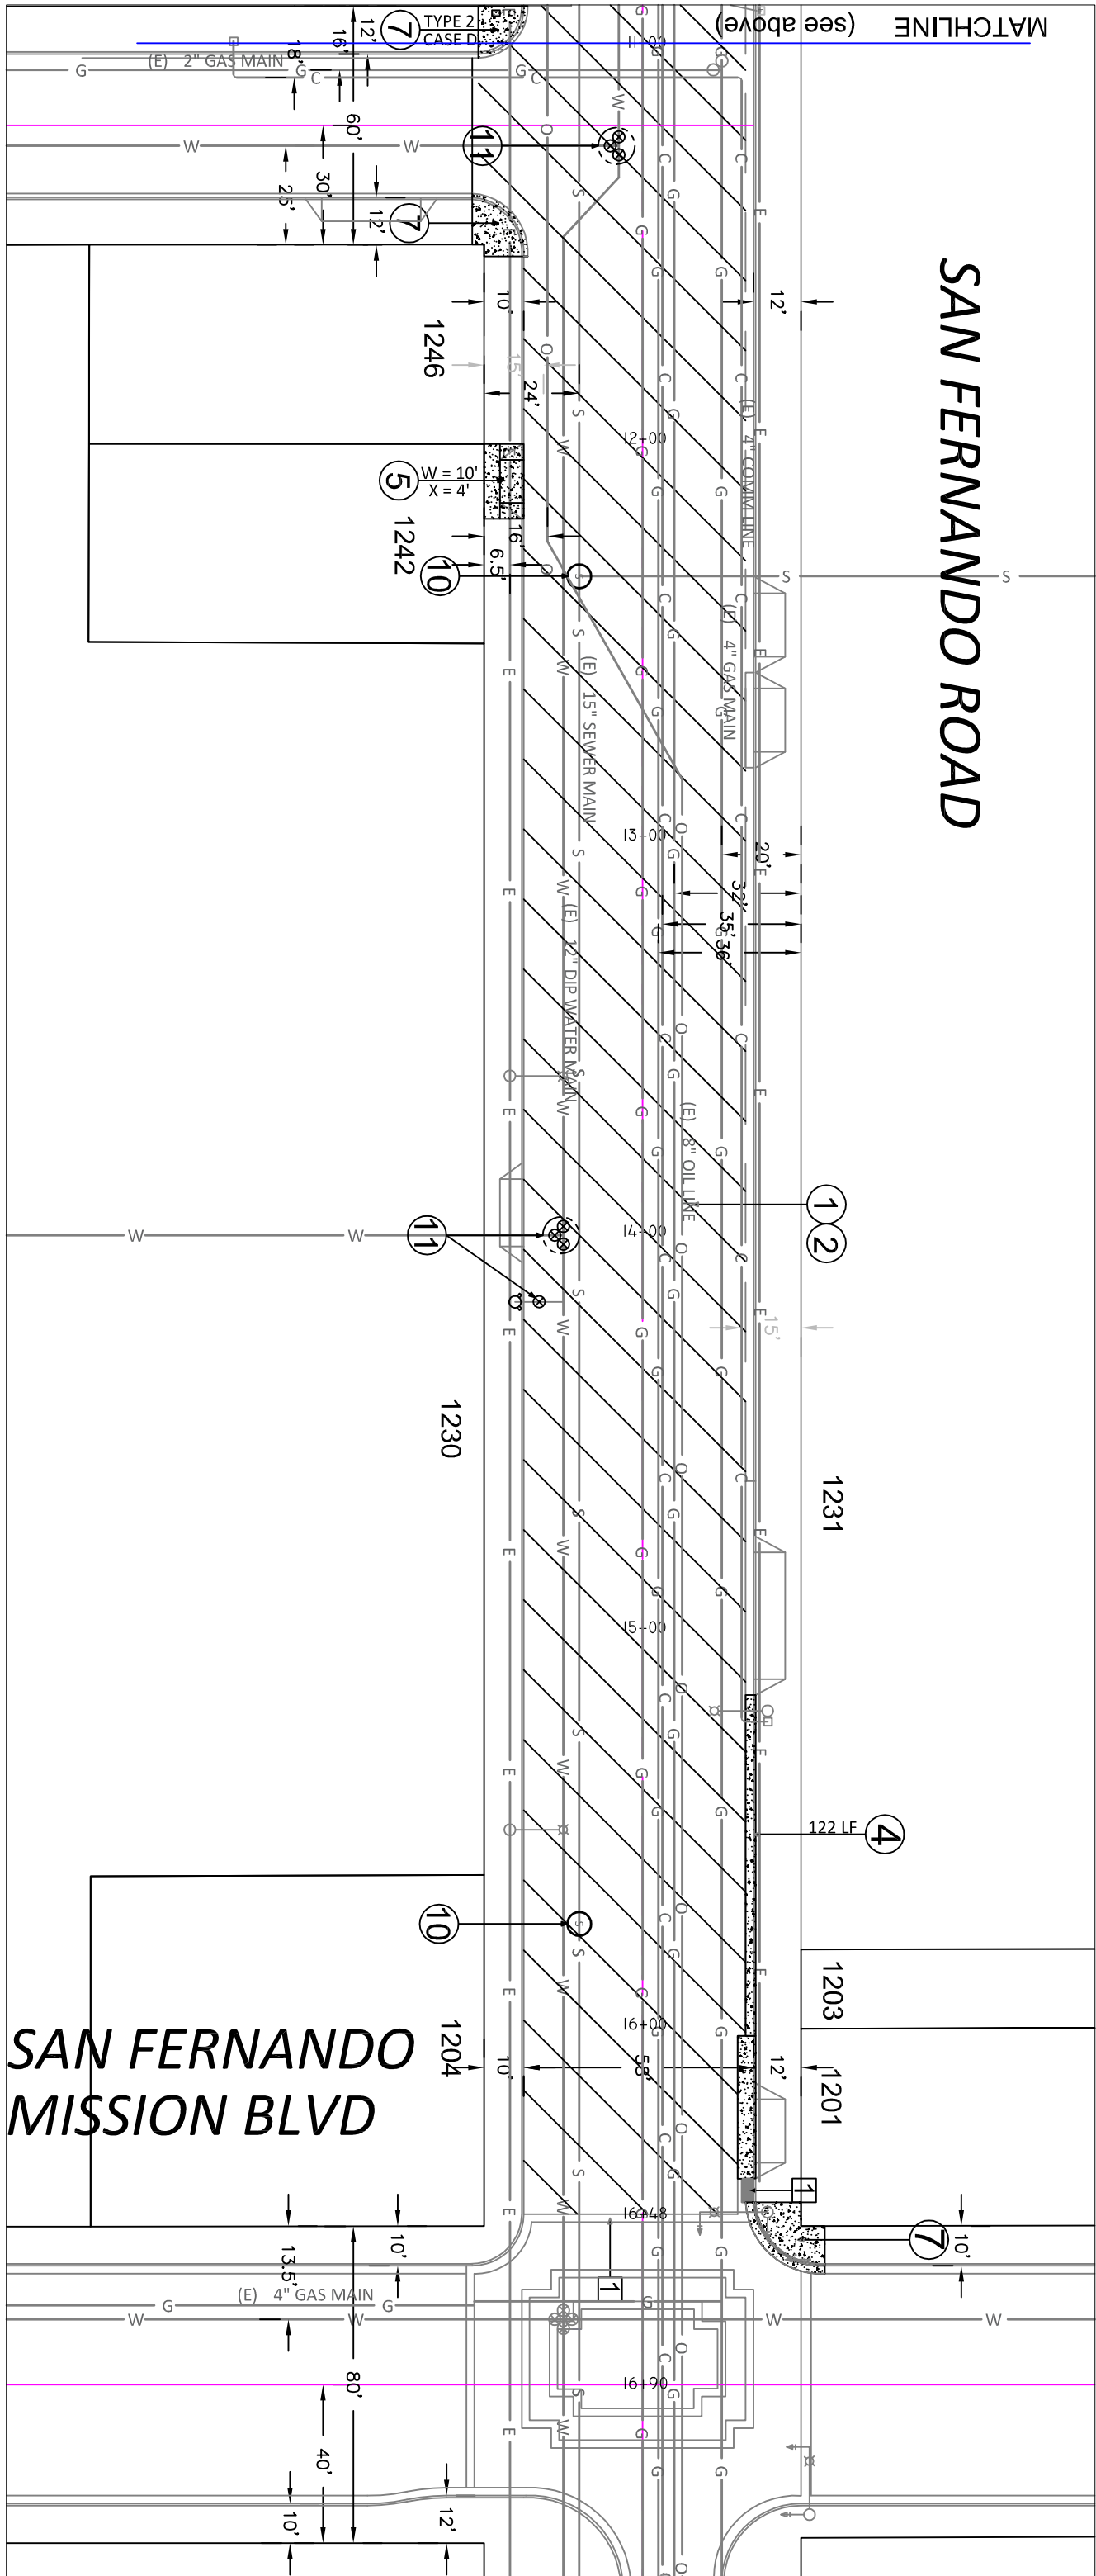

SAN FERNANDO RD BETWEEN S HUNTINGTON ST AND
SAN FERNANDO MISSION BLVD

UNDERGROUND SERVICE ALERT				REVISIONS				MANDUEL FABIAN CIVIL ENGINEERING ASSISTANT II				SAN FERNANDO PUBLIC WORKS DEPARTMENT			
REV.	DATE	BY	DESCRIPTION	APPROVED	REV.	DATE	BY	DESCRIPTION	APPROVED	DATE	DATE	SAN FERNANDO ROAD STREET IMPROVEMENTS BETWEEN S HUNTINGTON STREET AND SAN FERNANDO MISSION BLVD PAVING PLAN			
										8/30/18	8/30/18	CDBG PROJECT NO. 601994-18 PROJECT NO. 7606, PLAN NO. P-729			
												SHEET NO. 2 OF 3			

